


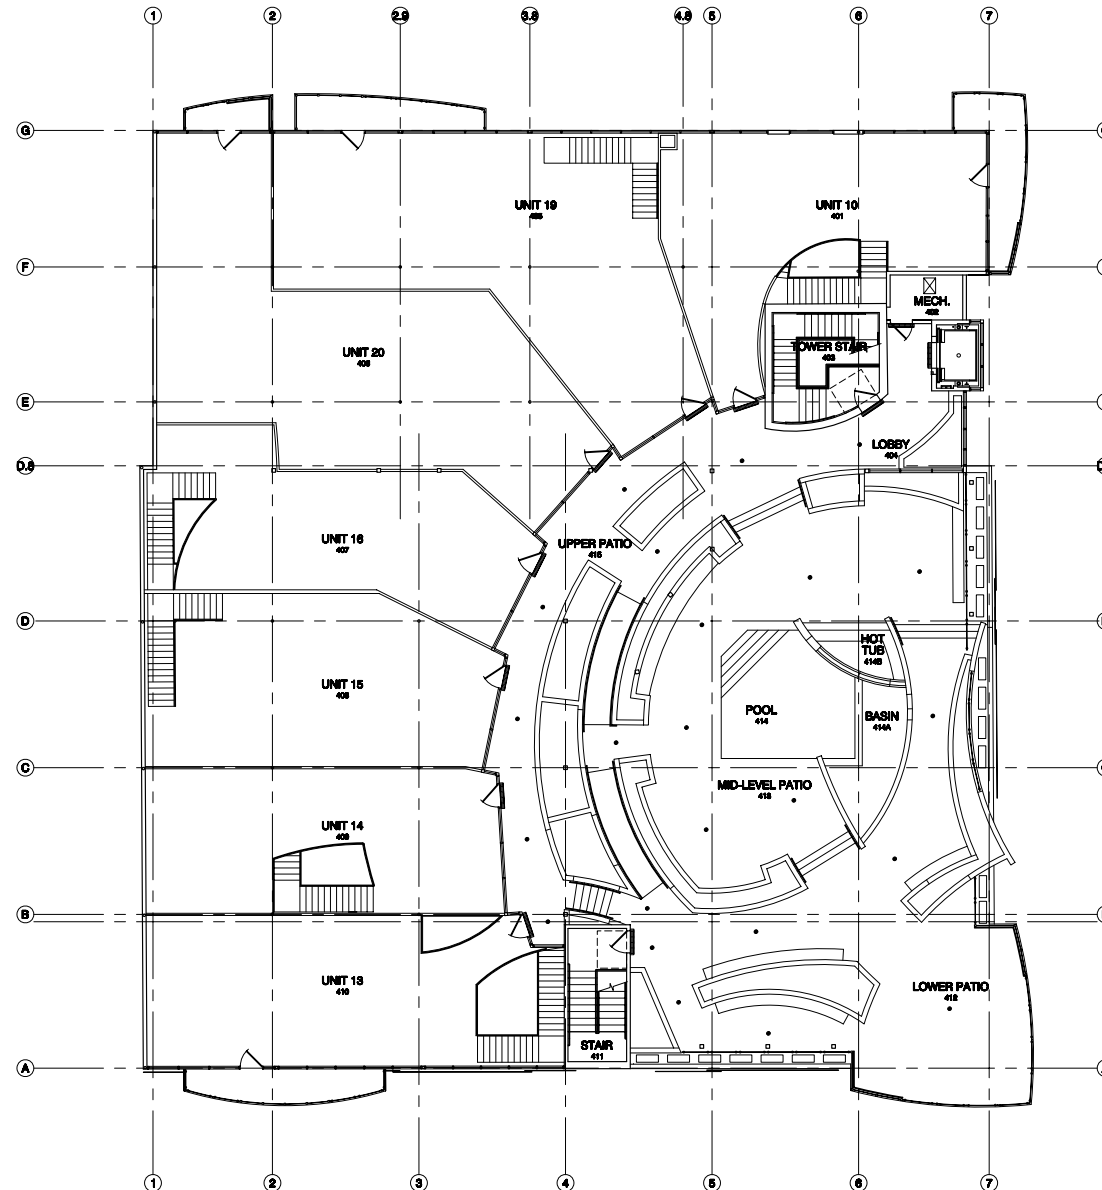

Fourth Level Overall Floor Plan

SCALE: 1/8" = 1'-0"

Key Notes

1. REF. EXISTING OPENING WITH METAL STUD WALLS BETWEEN DWELLING UNITS, CORRIDOR WALL, AND SHWY ENCLOSURES TO BE RATED FOR 1-HOUR.
2. REF. EXISTING WINDOW OPENING WITH CMU WALL, NORTH AND WEST EXTERIOR WALLS TO BE RATED FOR 1-HOUR.
3. REF. EXISTING WINDOW OPENING WITH CMU WALL, NORTH AND WEST EXTERIOR WALLS TO BE RATED FOR 1-HOUR.
4. SLOPE SIDEWALK LESS THAN 1:20. NO HANDRAILS REQUIRED.
5. ACCESSIBLE STAIRS AND HANDRAILS TO CODE.
6. NEW PLASTER PROVIDE DRAINAGE THROUGH DRAIN PIPED TO DRAINAGE AT ADJACENT FLOOR DECK.
7. 1-HOUR RATED PARTITION BETWEEN DWELLING UNITS, WINDOW ASSEMBLY TO DECK.
8. 1-HOUR RATED PARTITION WINDOW ASSEMBLY TO DECK.
9. REPAIR - REF. DETAILS.
10. ROOF TRELLIS AND COLUMN REF. DETAILS AND STRUCTURAL DRAWINGS.
11. FINISH - REF. DETAIL.
12. 4" DIAMETER ROOF DRAIN PROVIDE FEEDER LINE TO GRADE - REF. PLUMBING.
13. PROVIDE TYPED RIGID INSULATION IN ACCORDANCE WITH MANUFACTURER REQUIREMENTS.
14. 4" DIAMETER OVERFLOW ROOF DRAIN - REF. PLUMBING.
15. FLOOR DRAIN REF. DETAILS AND PLUMBING PLANS.
16. FINISH DRAIN W/ ACCESSIBLE PERFORATED STEEL COVER REF. PLUMBING.
17. CEILING/ROOF CEILING TO REMAIN UNPRESSED TIE / FLIGHT AND FINISH WHITE, PROVIDE 1-HOUR CEILING THROUGHOUT.
18. METAL LIP-IN TILES OVER RATED S.A. CLG. - REF. FINISH & MATERIAL SCHEDULE.
19. METAL SLOTTED REF. DETAILS AND FINISH SCHEDULES.
20. NEW BALCONY WITH 4" GAWARD, TO CODE - REF. DETAILS.
21. OPEN TO BELOW PROVIDE 4" GAWARD, TO CODE.
22. POOL NEGATIVE EDGE.
23. ACCESSIBLE RAMP W/ BAL. SLOPE 1:12. PROVIDE HANDRAILS TO CODE - REF. DETAILS.
24. 4" RISER, 11" TREAD, PROVIDE HANDRAIL ON BOTH SIDES OF STAIRS TO CODE.
25. 1-HR FIRE RATED NEW EXTERIOR WEL. STUD WALL. REF. AND FOR FIRE RATING DETAILS.
26. PROVIDE CAME DETECTION IN ACCORDANCE WITH CODE - REF. DETAILS.
27. 3-HOUR FIRE RATED NEW CMU WALL. IN ACCORDANCE W/ 2003 IBC FIRE RATED ASSEMBLY 3-1.4, TABLE 703.1(2).
28. 4" HIGH CURB/RAIL/WALL TO CODE - REF. DETAILS.
29. 3/4" HIGH HANDRAIL TO CODE - REF. DETAILS.
30. EDGE OF BAL. WALK.
31. ALUMINUM HANDRAILS - T.B.D.
32. END OF RAMP.
33. EDGE OF HANDRAIL W/ 4" METAL GUTTER - REF. DETAILS.
34. 4" SQUARE DOWNPOUT - REF. DETAILS.
35. EDGE OF SECOND LEVEL FLOOR LINE PROVIDE 4" RAILING TO CODE, REF. DETAILS.
36. EDGE OF END OF RAMP.
37. EXISTING CONCRETE COLUMN TO REMAIN. REF. STRUCT FOR MODIFICATIONS.
38. 3/4" HALF WALL WALL. REF. DETAIL.
39. POUR NEW CONC. FLOOR OVER EXIST. RAMP AND STEPS.
40. ELEVATOR CAB W/ GLASS BACK AND PARTIAL GLASS SIDES. REF. SPEC. SCHED.
41. CHANGE LINE AND SUMP PUMP. REF. PLUMBING PLAN.
42. EXIST. CONC. CURB.
43. RAMP LENS 6" 1/2" A.F.S. MEASURED FROM SECOND FLOOR.
44. NEW STEEL COL. REF. STRUCT.
45. COLUMN W/ W. WALL. REF. STRUCT.
46. MECH. UNITS. AREA REF. MECH. PLANS FOR SIZE, NUMBER, LOCATIONS AND CLEARANCE.
47. ROOF TOP MECH. ROOM.
48. ROOF PANELS OVER RATED S.A. CEILING.
49. FIRE EXTINGUISHER. LOCATE 7'0" O.C. IN EACH DWELLING UNIT. INSTALL IN ACCORDANCE W/ FIRE CODE.
50. EXIST. SIGN TO CODE. REF. ELEC.
51. CURVED TILE IDEAL. FILL SPACE W/ METALLIC WOODING.
52. FLOOR FLOORING TRANSITION. REF. ACCESSIBILITY DETAILS.
53. 1-HOUR FIRE RATED NEW CMU WALL. IN ACCORDANCE W/ 2003 IBC FIRE RATED ASSEMBLY 3-1.4, TABLE 703.1(2).
54. 1-HOUR FIRE RATED NEW DOUBLE WEL. STUD WALL. REF. AND FOR FIRE RATING DETAILS.
55. SPRINKLER RISER. REF. SPRINKLER SHOP DRAWINGS.
56. STEEL SHW STR. W/ COATED RISER. INSTALL ALL COMPONENTS IN ACCORDANCE W/ ALL CODES. FIELD MEASURE EXIST. STRUCTURE PRIOR TO PRODUCTION OF SHW SHOP DRAWINGS.
57. ALUM. NEW MESH ROOM WALL W/ STAR ENCLOSURE WALL BELOW.
58. PROVIDE CAME DETECTION UNDER COMPANY AREA. CAME. REF. ACCESS. DETLS.
59. UTILITY SINK. REF. PLUMBING. PROVIDE ADEQUATE CLEARANCES FOR SPRINKLER RISER. REF. SPRINKLER SHOP DRAWINGS.
60. NEW STEEL COLUMN JAMB. REF. STRUCT.
61. RAMP COLUMN W/ METAL STUD FURROUT, S.A. OVER FURROUT AND BRICK.
62. EXTERIOR DOOR. FINISHED - PROVIDE MAX. STEP AT THRESHOLD. REF. ACCESSIBILITY DETAILS A001.
63. 1-HOUR FIRE RATED EXIST. CMU WALL. IN ACCORDANCE W/ 2003 IBC FIRE RATED ASSEMBLY 3-1.4, TABLE 703.1(2).
64. 1/4" METAL PLANTERS. REF. DETAILS. CONSULT LANDSCAPE ARCHITECT PRIOR TO CONCT.
65. 4" FINISH. PROVIDE FINISHING IN ACCORDANCE WITH MANUF. RECOMMENDATIONS CONSULT WATER FINISHING MANUF. AND INSTALLED PRIOR TO CONCT.
66. STONE VENEER - STONE 1 - REF. SPEC. SCHED. INSTALL PER MANUF. REITS.
67. STONE VENEER - STONE 2 - REF. SPEC. SCHED. INSTALL PER MANUF. REITS.
68. STONE VENEER - STONE 3 - REF. SPEC. SCHED. INSTALL PER MANUF. REITS.
69. ARCHITECTURAL WIRE MESH - MESH 1 - REF. SPEC. SCHED. INSTALL PER MANUF. REITS.
70. ARCHITECTURAL WIRE MESH - MESH 2 - REF. SPEC. SCHED. INSTALL PER MANUF. REITS.
71. STONE VENEER - STONE 1 - REF. SPEC. SCHED. INSTALL PER MANUF. REITS.
72. 1-HOUR FIRE RATED EXIST. MASONRY WALL TO BE IN ACCORDANCE W/ 2003 IBC FIRE RATED ASSEMBLY 1-1.2, TABLE 703.1(2).
73. 3/4" FULL EXIST. OPENING W/ 3-HR FIRE RATED 4" CMU BLOCK WALL.
74. REMOVE PORTION OF WALL TO ACCOMMODATE NEW 8'-0" WIDE DOOR OPENING.
75. 3-HOUR FIRE RATED EXIST. BRICK MASONRY WALL. IN ACCORDANCE W/ 2003 IBC FIRE RATED ASSEMBLY 1-1.2, TABLE 703.1(2).
76. 4"x4" GUTTER W/ 3/4" DOWNPOUT TO ROOF BELOW.
77. REEXISTING STAIRS. HANDRAILS AND GUARDS TO CODE. REF. STAIR AND RAILING DETAILS.
78. ALUM. PANELS W/ RAIL. REF. DETAIL.
79. 3/4" TEMP. GLASS RAILING REF. DETAIL.
80. FINISH AREA DRAIN. SLOPE TO DRAIN. REF. PLUMB.
81. REF. EXISTING DOOR OPENING WITH CMU WALL. EXTERIOR WALL TO BE RATED FOR 1-HOUR.
82. 3/4"x1/4" STEEL TIE. ANCHOR SET TO CONCRETE - CONCRETE SHAPE PLACES IN WALL.
83. 1-HR FIRE RATED CEILING/DOOR ASSEMBLY PROVIDE 1-HR RATED WALL ASSEMBLY AROUND ALL EDGES OF RATED FLOOR AREA. REF. HATCHED AREA ON FIRE PROTECTION PLANS. WHERE NO WALL IS SHOWN ON PLAN, FINISH 1-HR WALL W/IN FLOOR SPACE. INSULATION IS NOT PERMITTED IN FLOOR/CEILING ASSEMBLY.
84. POOL BY OTHERS.
85. OVERFLOW AREA DRAIN SLOPE UP SUCH THAT OVERFLOW DRAIN IS 2" HIGHER THAN PRIMARY DRAIN. CONCRETE. BELOW BRICK. REF. PLUMBING.
86. PROVIDE FURROUT AROUND BEAM WHERE BEAM PROJECTS FROM WALL. MATCH BEAM FURROUT AT COLUMN.
87. FURROUT AROUND EXIST. CONC. BEAM. BEAM. WITH OF BEAM TO MATCH OVERALL WIDTH OF FURROUT OUT COLUMN BS. REF. DETAILS.
88. FURROUT AT STEEL COLUMN TO MATCH FURROUT OF CONC. COLUMN BELOW.
89. CIRCULAR FINISHING. REF. FINISH SCHEDULE.
90. TRAMP A MATERIAL. REF. POOL DRAWINGS BY OTHERS.
91. NEW FOUNDATION REF. STRUCT.
92. NEW FLOOR SYSTEM REF. STRUCT.
93. EXIST. FLOOR SYSTEM. REF. STRUCT & DETAIL SCHED.
94. EXIST. FOUNDATION REF. STRUCT & DETAIL SCHED.
95. CONCRETE SPACE TO BE CONCRETE. PROVIDE VENTILATION & ACCESS PANEL.
96. EXIST. MASONRY WALL.
97. NEW HEADER FOR NEW OPENING IN MASONRY WALL. PROVIDE TEMPORARY SHORING DURING REMOVAL OF WALL. REF. STRUCT FOR HEADER REQUIREMENTS.
98. NEW ROOF ASSEMBLY. REF. DETAILS AND STRUCT. DRAWINGS.
99. PROVIDE 16" x 24" ACCESS PANEL INTO CHASE SPACE.
100. PROVIDE CHANGE A PUMP FOR SPACE BEHIND WALL. REF. PLUMB.
101. 4" STEP IN FINISH.

NOT FOR CONSTRUCTION


AP Equity
1300 Guadalupe Street
Austin, TX

N-VIZION
FOR ARCHITECTS - ENVIRONMENTAL IMAGES

Fourth Level Overall Floor Plan
Drawn By: S.H. / Checked By: S.H.
Date: 03/10/2007
Project: 03/10/2007
Drawn By: S.H. / Checked By: S.H.
Date: 03/10/2007
Project: 03/10/2007

Drawn By: S.H.	03/10/2007
Checked By: S.H.	03/10/2007
Project: 03/10/2007	03/10/2007

A124

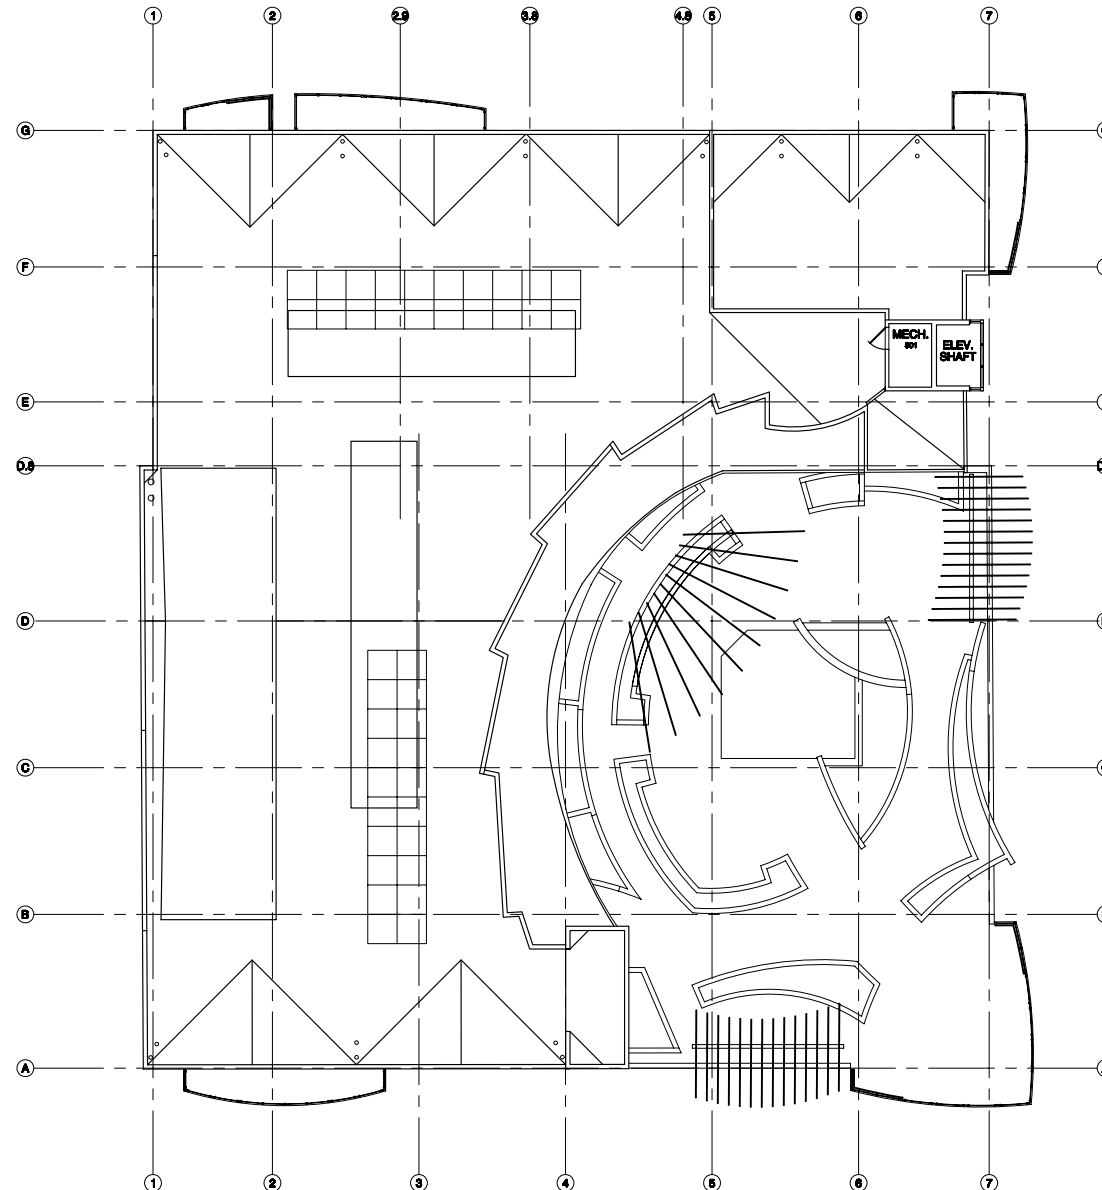

Roof Level Overall Floor Plan

SCALE: 1/8" = 1'-0"

Key Notes

1. REPAIR EXISTING OPENING WITH METAL STUD WALLS BETWEEN DWELLING UNITS, CORRIDOR WALL, AND SHAWT ENCLOSURES TO BE WAITED FOR 1-HOUR.
2. REPAIR EXISTING OPENING WITH METAL STUD WALLS BETWEEN DWELLING UNITS, CORRIDOR WALL, AND SHAWT ENCLOSURES TO BE WAITED FOR 1-HOUR.
3. REPAIR EXISTING WINDOW OPENING WITH CMU WALL. NORTH AND WEST EXTERIOR WALLS TO BE WAITED FOR 1-HOUR.
4. ROOF TRELLIS AND COLLARS REF. DETAILS AND STRUCTURAL DRAWINGS.
5. ACCESSIBLE STAIRS AND HANDRAILS TO CODE.
6. NEW FLOOR FINISH PROVIDE DRAINAGE THROUGH DRAIN PIPES TO DRAINAGE AT ADJACENT FLOOR DECK.
7. 1-HOUR RATED PARTITION BETWEEN DWELLING UNITS. MANUFACTURER'S REQUIREMENTS.
8. 1-HOUR RATED PARTITION MANUFACTURER ASSEMBLY TO DECK.
9. REPAIR - REF. DETAILS.
10. ROOF TRELLIS AND COLLARS REF. DETAILS AND STRUCTURAL DRAWINGS.
11. FINISH - REF. DETAILS.
12. 4" DIAMETER ROOF DRAIN PROVIDE FEEDER LINE TO DRAIN - REF. PLUMBING.
13. PROVIDE TYPED ROOF INSULATION IN ACCORDANCE WITH MANUFACTURER'S REQUIREMENTS.
14. 4" DIAMETER OVERFLOW ROOF DRAIN - REF. PLUMBING.
15. FLOOR DRAIN REF. DETAILS AND PLUMBING PLANS.
16. PROVIDE DRAIN W/ ACCESSIBLE PERFORATED STEEL COVER REF. PLUMBING.
17. OVERSTOCK CEILING TO REMAIN UNPRESSED TIE / FLIGHT AND FINISH WHITE. PROVIDE 1-HOUR CEILING THROUGHOUT.
18. METAL LIP-IN TILES OVER RATED S.S. CLG. - REF. FINISH & MATERIAL SCHEDULE.
19. METAL SOFFIT REF. DETAILS AND FINISH SCHEDULES.
20. NEW BALCONY WITH 4" GAWARDAL TO CODE - REF. DETAILS.
21. OPEN TO BELOW PROVIDE 4" GAWARDAL TO CODE.
22. POOL NEARBY EDGE.
23. ACCESSIBLE RAMP W/ METAL SLIP 1-1/2. PROVIDE HANDRAILS TO CODE - REF. DETAILS.
24. 4" RISER, 11" TREAD. PROVIDE HANDRAIL ON BOTH SIDES OF STAIRS TO CODE.
25. 1-HR FIRE RATED NEW EXTERIOR WEL STUD WALL. REF. AND FOR FIRE RATING DETAILS.
26. PROVIDE CAME DETECTION IN ACCORDANCE WITH CODE - REF. DETAILS.
27. 3-HOUR FIRE RATED NEW CMU WALL IN ACCORDANCE W/ 2003 IBC FIRE RATED ASSEMBLY 3-1.4, TABLE 703.1(2).
28. 4" HIGH CHAIRING/HANDRAIL TO CODE - REF. DETAILS.
29. 3/4" HIGH HANDRAIL TO CODE - REF. DETAILS.
30. EDGE OF STAIR WALK.
31. ALUMINUM HANDRAILS - T.B.D.
32. END OF RAMP.
33. EDGE OF HANDRAIL W/ 4" METAL GUARD - REF. DETAILS.
34. 4" SQUARE DOWNPOUT - REF. DETAILS.
35. EDGE OF SECOND LEVEL. FLOOR LINE PROVIDE 4" RAILING TO CODE, REF. DETAILS.
36. EDGE OF END OF RAMP.
37. EXISTING CONCRETE COLUMN TO REMAIN. REF. STRUCT FOR MODIFICATIONS.
38. 3/4" WALL HALF WALL. REF. DETAIL.
39. POUR NEW CONC. FLOOR OVER EXIST. RAMP AND STEPS.
40. ELEVATOR CAB W/ GLASS BACK AND PARTIAL GLASS SIDES. REF. SPEC SCHED.
41. CHANGE CASE AND SHAWT RAMP. REF. PLUMBING PLAN.
42. EXIST. CONC. CORE.
43. FINISH LEVELS 0'-0" TO 1'-0" A.F.S. MEASURED FROM SECOND FLOOR.
44. NEW STEEL ST. COL. REF. STRUCT.
45. COLUMN W/ IN WALL. REF. STRUCT.
46. MECH. UNITS. AREA REF. MECH. PLANS FOR SIZE, NUMBER, LOCATIONS AND CLEARANCE.
47. ROOF TOP MECH. ROOM.
48. ROOF PANELS OVER RATED S.S. CEILING.
49. FIRE EXTINGUISHER. LOCATE 7' O.C. W/ ONE IN EACH DWELLING UNIT. INSTALL IN ACCORDANCE W/ FIRE CODE.
50. EXIST. SIGN TO CODE. REF. ELEC.
51. CURVED TILE EDGE. FILL SPACE W/ METALLIC WOODING.
52. FLOOR FINISH. MANUFACTURER REF. ACCESSIBILITY DETAILS.
53. 1-HOUR FIRE RATED NEW CMU WALL IN ACCORDANCE W/ 2003 IBC FIRE RATED ASSEMBLY 3-1.4, TABLE 703.1(2).
54. 1-HOUR FIRE RATED NEW DOUBLE WEL STUD WALL. REF. AND FOR FIRE RATING DETAILS.
55. SPRINKLER RISER. REF. SPRINKLER SHOP DRAWINGS.
56. STEEL SHAWT STR. W/ COATED RISERS. INSTALL ALL COMPONENTS IN ACCORDANCE W/ ALL CODES. FIELD MEASURE EXIST. STRUCTURE PRIOR TO PRODUCTION OF SHAWT SHOP DRAWINGS.
57. ALUM. NEW MESH ROOM WALL W/ STAIR ENCLOSURE WALL BELOW.
58. PROVIDE CAME DETECTION UNDER CORRIDOR AREA. CAME. REF. ACCESSIBLE.
59. UTILITY SINK. REF. PLUMBING. PROVIDE ADEQUATE CLEARANCES FOR SPRINKLER RISER. REF. SPRINKLER SHOP DRAWINGS.
60. NEW STEEL COLUMN JAMB. REF. STRUCT.
61. RAMP COLUMN W/ METAL STUD FURROUT, S.S. OVER FURROUT AND BRICK.
62. EXTERIOR DOOR. FINISHED - PROVIDE MET. STEP AT THRESHOLD. REF. ACCESSIBILITY DETAILS A001.
63. 1-HOUR FIRE RATED EXIST. CMU WALL IN ACCORDANCE W/ 2003 IBC FIRE RATED ASSEMBLY 3-1.4, TABLE 703.1(2).
64. 15"x15" METAL PLANTERS. REF. DETAILS. CONSULT LANDSCAPE ARCHITECT PRIOR TO CONCT.
65. 8" FINISH. PROVIDE FINISHING IN ACCORDANCE WITH MANUF. RECOMMENDATIONS CONSULT WATER FINISHING MANUF. AND INSTALL PRIOR TO CONCT.
66. STONE VENEER - STONE 1 - REF. SPEC. SCHED. INSTALL PER MANUF. REQS.
67. STONE VENEER - STONE 2 - REF. SPEC. SCHED. INSTALL PER MANUF. REQS.
68. STONE VENEER - STONE 3 - REF. SPEC. SCHED. INSTALL PER MANUF. REQS.
69. ARCHITECTURAL WIRE MESH - MESH 1 - REF. SPEC. SCHED. INSTALL PER MANUF. REQS.
70. ARCHITECTURAL WIRE MESH - MESH 2 - REF. SPEC. SCHED. INSTALL PER MANUF. REQS.
71. STONE VENEER - STONE 1 - REF. SPEC. SCHED. INSTALL PER MANUF. REQS.
72. 1-HOUR FIRE RATED EXIST. MASONRY WALL TO BE IN ACCORDANCE W/ 2003 IBC FIRE RATED ASSEMBLY 3-1.4, TABLE 703.1(2).
73. 1-HOUR FIRE RATED EXIST. MASONRY WALL TO BE IN ACCORDANCE W/ 2003 IBC FIRE RATED ASSEMBLY 3-1.4, TABLE 703.1(2).
74. REMOVE PORTION OF WALL TO ACCOMMODATE NEW 8'-0" WIDE DOOR OPENING.
75. 3-HOUR FIRE RATED EXIST. BRICK MASONRY WALL IN ACCORDANCE W/ 2003 IBC FIRE RATED ASSEMBLY 3-1.4, TABLE 703.1(2).
76. 4"x4" OUTLET W/ 3/4" DOWNPOUT TO ROOF BELOW.
77. REPAIRING STAIRS. HANDRAILS AND GUARDS TO CODE. REF. STAIR AND HANDRAIL DETAILS.
78. ALUM. PANELS W/ RAIL. REF. DETAIL.
79. 3/4" TAMP GLASS RAILING REF. DETAIL.
80. FINISH AREA DRAIN. SLOPE TO DRAIN. REF. PLUMB.
81. REPAIR EXISTING DOOR OPENING WITH CMU WALL. EXTERIOR WALL TO BE WAITED FOR 1-HOUR.
82. 3/4"x1/4" STEEL TIE. ANCHOR SET TO CONCRETE - CONCRETE SHAPE PLACES IN WALL.
83. 1-HR FIRE RATED CEILING/FLOOR ASSEMBLY PROVIDE 1-HR RATED WALL ASSEMBLY AROUND ALL EDGES OF RATED FLOOR AREA. REF. HATCHED AREA ON FIRE PROTECTION PLANS. WHERE NO WALL IS SHOWN ON PLANS FINISH 1-HR WALL W/ FIN. FLOOR SPACE. INSULATION IS NOT PERMITTED IN FLOOR/CEILING ASSEMBLY.
84. POOL BY OTHERS.
85. OVERFLOW AREA DRAIN SLOPE UP SUCH THAT OVERFLOW DRAIN IS 2" HIGHER THAN PRIMARY DRAIN. CONCRETE. BELOW FINISH. REF. PLUMBING.
86. PROVIDE FURROUT AROUND BEAM WHERE BEAM PROJECTS FROM WALL. MATCH BEAM FURROUT AT COLUMN.
87. FURROUT AROUND EXIST. CONC. BEAM. OVERALL WIDTH OF BEAM TO MATCH OVERALL WIDTH OF FURROUT OUT COLUMN BS. REF. DETAILS.
88. FURROUT AT STEEL COLUMN TO MATCH FURROUT OF CONC. COLUMN BELOW.
89. CORRIDOR FINISHING. REF. FINISH SCHEDULE.
90. FINISH FLOOR SYSTEM REF. STRUCT.
91. NEW FLOOR SYSTEM REF. STRUCT.
92. EXIST. FLOOR SYSTEM. REF. STRUCT & DETAIL SCHED.
93. EXIST. FLOOR SYSTEM. REF. STRUCT & DETAIL SCHED.
94. EXIST. FLOOR SYSTEM. REF. STRUCT & DETAIL SCHED.
95. EXIST. FLOOR SYSTEM. REF. STRUCT & DETAIL SCHED.
96. EXIST. FLOOR SYSTEM. REF. STRUCT & DETAIL SCHED.
97. NEW FINISH FOR NEW OPENING IN MASONRY WALL. PROVIDE TEMPORARY SHORING DURING REMOVAL OF WALL. REF. STRUCT FOR SHORING REQUIREMENTS.
98. NEW ROOF ASSEMBLY. REF. DETAILS AND STRUCT. DRAWINGS.
99. PROVIDE 18" x 24" ACCESS PANEL INTO CHASE SPACE.
100. PROVIDE DRAINAGE A PUMP FOR SPACE BEHIND WALL. REF. PLUMB.
101. 4" STEP IN FINISH.

NOT FOR CONSTRUCTION

AP Equity
1300 Guadalupe Street
Austin, TX

N-VIZION
FOR ARCHITECTS - ENVIRONMENTAL IMAGES

Roof Level Overall Floor Plan
Drawn By: S.H. (C) 2008 N-VIZION
Austin, TX 78746 (512) 227-8901 (512) 227-8906

Client:	AP Equity
Project:	1300 Guadalupe
Drawn By:	S.H.
Check By:	S.H.
Date:	08/14/08

A125